


**PLUMBING GENERAL NOTES:**

1. FOR CONTINUATION OF SITE SERVICES REFER TO SITE SERVICE DRAWING BY OTHERS. CO-ORDINATE EXACT LOCATION AND INVERTS OF SERVICES.
2. PROVIDE CLEANOUTS AND TRAP PRIMING FOR SANITARY AS REQUIRED BY O.B.C. AND LOCAL AUTHORITIES.
3. PROVIDE CLEANOUTS FOR STORM AS REQUIRED BY O.B.C. AND LOCAL AUTHORITIES.
4. PROVIDE COMPLETE PLUMBING VENT SYSTEM AS REQUIRED BY O.B.C. AND LOCAL AUTHORITIES, INCLUDING MIN. 3% VENT AT UPSTREAM END(S) OF SANITARY BUILDING DRAIN.
5. ROOF DRAINS SHALL BE ZURN MODEL Z-105-5 CONTROL FLOW, 1 NOTCH/WEIR.
6. PROVIDE SUFFICIENT SCUPPERS AT PERIMETER OF ROOF. BOTTOM OF SCUPPER SHALL BE 4" ABOVE ROOF DRAIN LEVEL. (BY GENERAL CONTRACTOR)

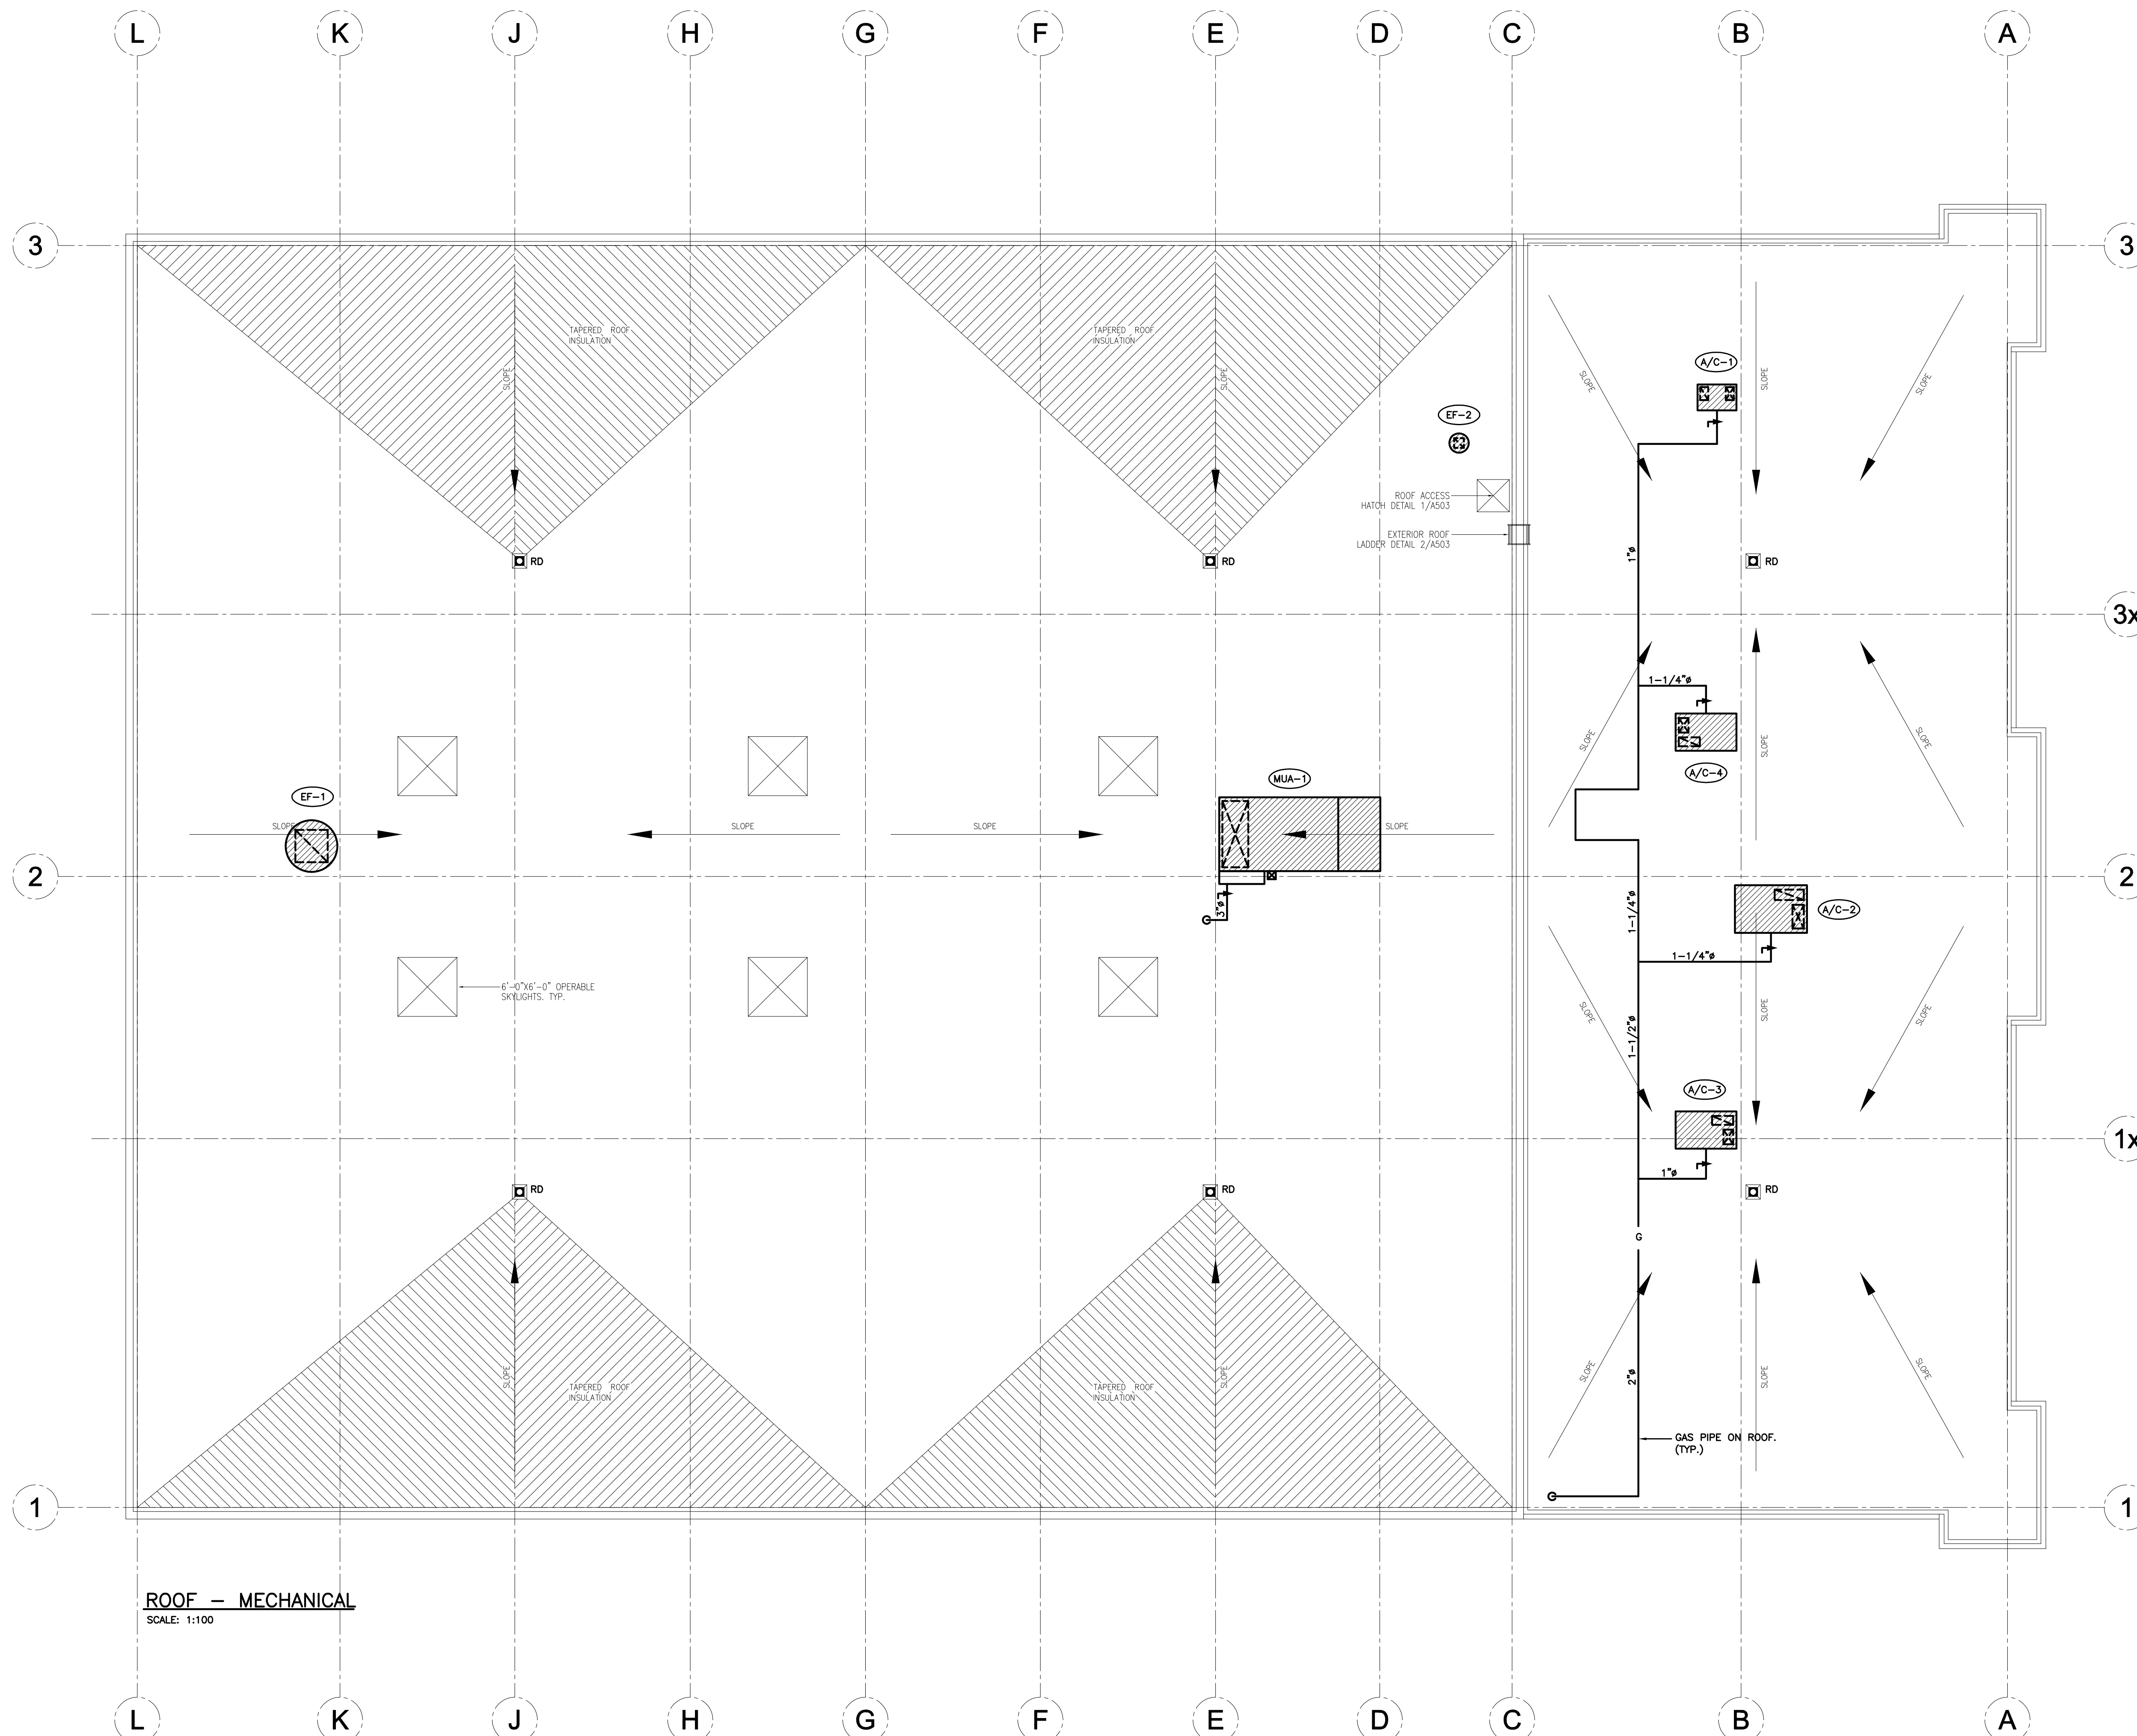

**ROOF — MECHANICAL**  
SCALE: 1:100

**GENERAL NOTES:**  
 IT IS THE CONTRACTOR'S RESPONSIBILITY TO:  
 1. USE SCALED DIMENSIONS IN PREFERENCE TO SIZING.  
 2. VERIFY AND CHECK ALL DIMENSIONS PRIOR TO AND DURING CONSTRUCTION.  
 3. DETERMINE LOCATIONS OF ALL EXISTING SERVICES.  
 4. PLANS ARE IN CONFORMANCE WITH THE ONTARIO BUILDING CODE.  
 ANY CHANGES, DISCREPANCIES, OR SUBSTITUTIONS SHALL BE REPORTED TO AND REVIEWED BY THE ENGINEER BEFORE PROCEEDING.

**TRINSTAR ENGINEERING**  
 Division of 1041546 Ontario Limited  
 30 West Beaver Creek Road, Unit #118  
 Richmond Hill, Ontario  
 Canada, L4B-3K1  
 (905) 882-1332  
 Fax: (905) 882-0736

| DATE:     | BY:  | CHK: |
|-----------|------|------|
| 04 JUN 10 | W.L. | W.L. |
| 01 JUN 10 | W.L. | W.L. |
| 01 JUN 10 | W.L. | W.L. |

REVISIONS:

| NO. | DESCRIPTION                | DATE |
|-----|----------------------------|------|
| 1.  | ISSUED FOR PERMIT & TENDER |      |
| 2.  | ISSUED FOR PERMIT & TENDER |      |
| 3.  | ISSUED FOR PERMIT & TENDER |      |
| 4.  | ISSUED FOR PERMIT & TENDER |      |
| 5.  | ISSUED FOR PERMIT & TENDER |      |
| 6.  | ISSUED FOR PERMIT & TENDER |      |
| 7.  | ISSUED FOR PERMIT & TENDER |      |
| 8.  | ISSUED FOR PERMIT & TENDER |      |
| 9.  | ISSUED FOR PERMIT & TENDER |      |
| 10. | ISSUED FOR PERMIT & TENDER |      |

PERSONAL:  PROFESSIONAL:  SITE PLAN:  SITE PAVK:  TENDER:  PERMIT:  CONTRIBUTION:  AS BUILT:  OTHER:



PROJECT OWNER:

**PROJECT NAME:** ATTRIDGE TRANSPORTATION  
 4130 HARVESTER ROAD  
**DRAWING NAME:** ROOF MECHANICAL PLAN

**DRAWN BY:** W.L. **CHECKED BY:** W.L.  
**DATE:** APRIL 2010 **SCALE:** 1:100

**PROJECT No.:** 210-073 **SET No.:**

**DRAWING No.:** M3